




**YOW Architects PC**  
Architecture & Planning

115 S. Weber Colorado Springs, Colorado 719-475-8133

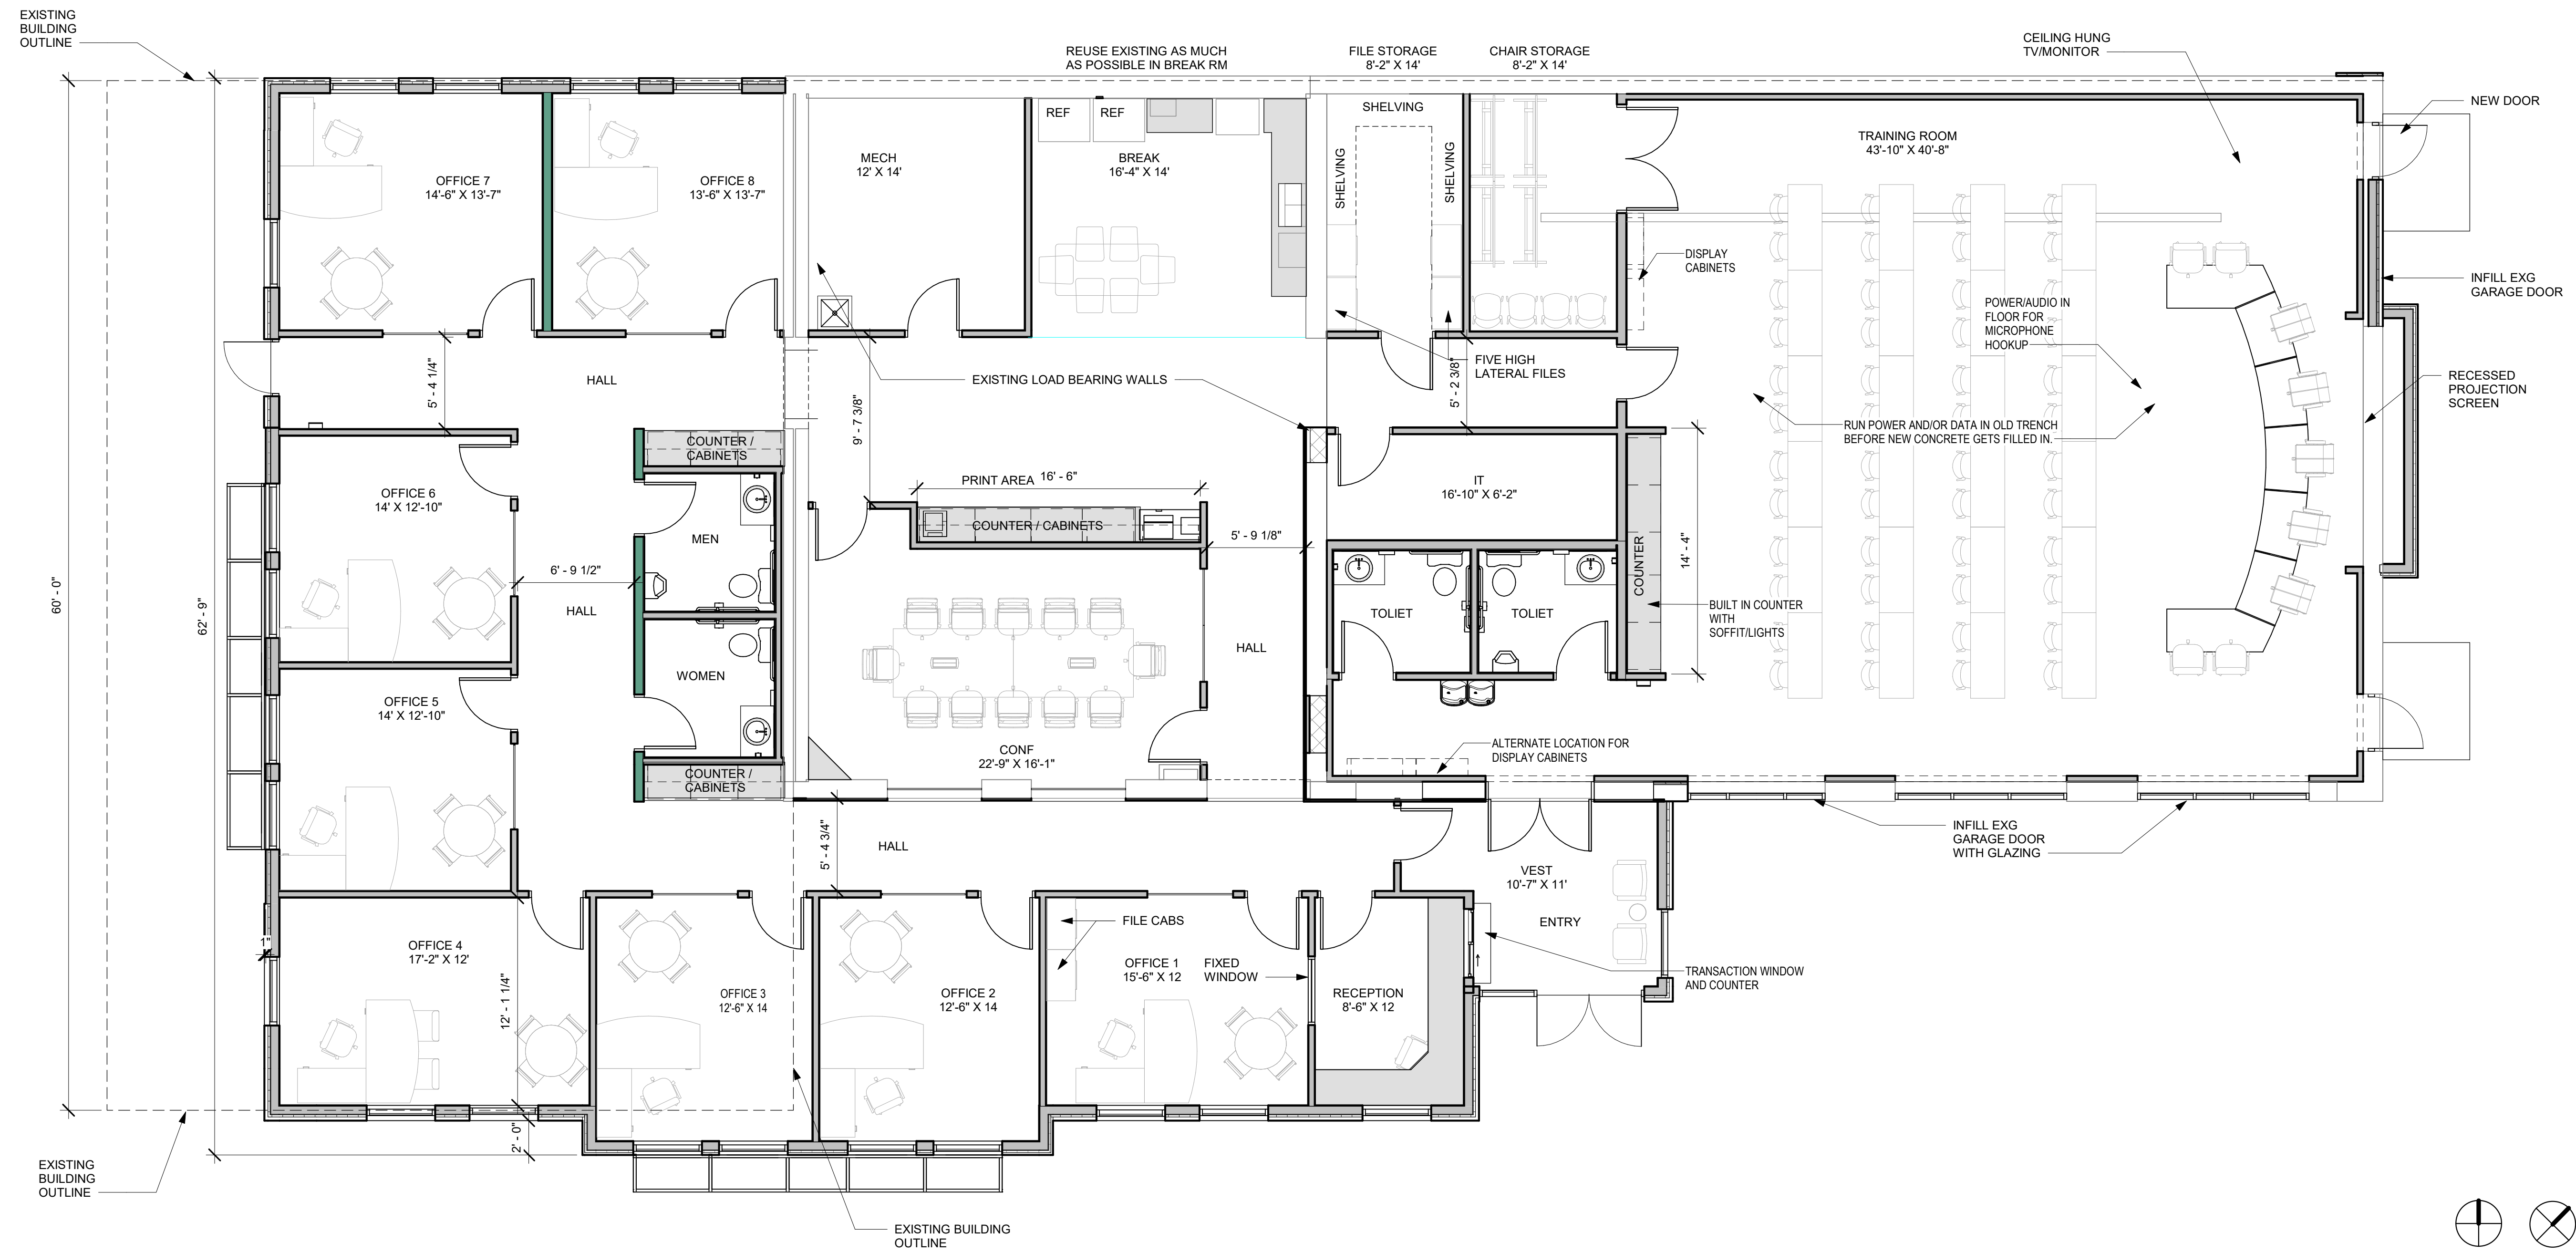

Revision Schedule

CONSTRUCTION DOCUMENTS  
NOT FOR CONSTRUCTION

**Falcon Fire Dept Admin Bldg**  
7030 OLD MERIDIAN RD  
PEYTON, CO 80831

Project Number  
**20.147**

Date  
11.18.2020

Drawn By  
ATT

Checked By  
YOW

**P2.1**  
Floor Plan - Presentation  
Scale  
3/16" = 1'-0"

**1** Floor Plan - Presentation  
3/16" = 1'-0"

